


Bair Blvd, New Stanton, PA 15672

Issued for Permit - 08.05.2016

Contractor:
TBD
??
??

Drawing List		
Sheet No.	Drawing Title	
Electrical		
E001	General Notes, Legends and Abbreviations	X
E002	Lighting Fixture Schedule	X
E101	Electrical Details-1	X
E102	Electrical Details-2	X
E103	Electrical Details-3	X
E104	Electrical Details-4	X
E200	Site Electrical Plan	X
E200A	Site Photometric Plan	X
E201	First Floor Power Plan	X
E202	First Floor Lighting Plan	X
E203	Second Floor Power Plan	X
E204	Second Floor Lighting Plan	X
E205	Third Floor Power & Lighting Plan	X
E206	Fourth Floor Power & Lighting Plan	X
E207	Roof Electrical Plan	X
E208	Enlarged Floor Power Plan-I	X
E209	Enlarged Floor Power Plan-II	X
E210	Enlarged Floor Power Plan-III	X
E301	Panel Schedule-I	X
E302	Panel Schedule-II	X
E303	Panel Schedule-III	X
E304	Electrical Riser Diagram	X
E305	Telephone, Data and TV Riser Diagram	X
FA-S01	Fire Alarm Riser Diagram	X
Plumbing		
P001	General Notes, Legends and Abbreviations	X
P101	Details-1	X
P102	Details-2	X
P201	First Floor Water & Gas Supply Plan	X
P202	First Floor Sanitary & Vent Supply Plan	X
P203	Second Floor Plumbing Plan	X
P204	Third & Fourth Floor Plumbing Plan	X
P205	Roof Plumbing Plan	X
P206	Unit Water Supply Plan	X
P207	Unit Sanitary & Vent Plan	X
P301	Unit Riser Diagram	X
P302	Water Supply Riser Diagram	X
P303	Sanitary & Vent Riser Diagram	X
P304	Storm Water Riser Diagram	X
P305	Gas Supply Riser Diagram	X
P401	Schedules	X
Fire Protection		
FP001	General Notes & Legends	X
FP101	First Floor Specification Plan	X
FP102	Second Floor Specification Plan	X
FP103	Third & Fourth Floor Specification Plan	X

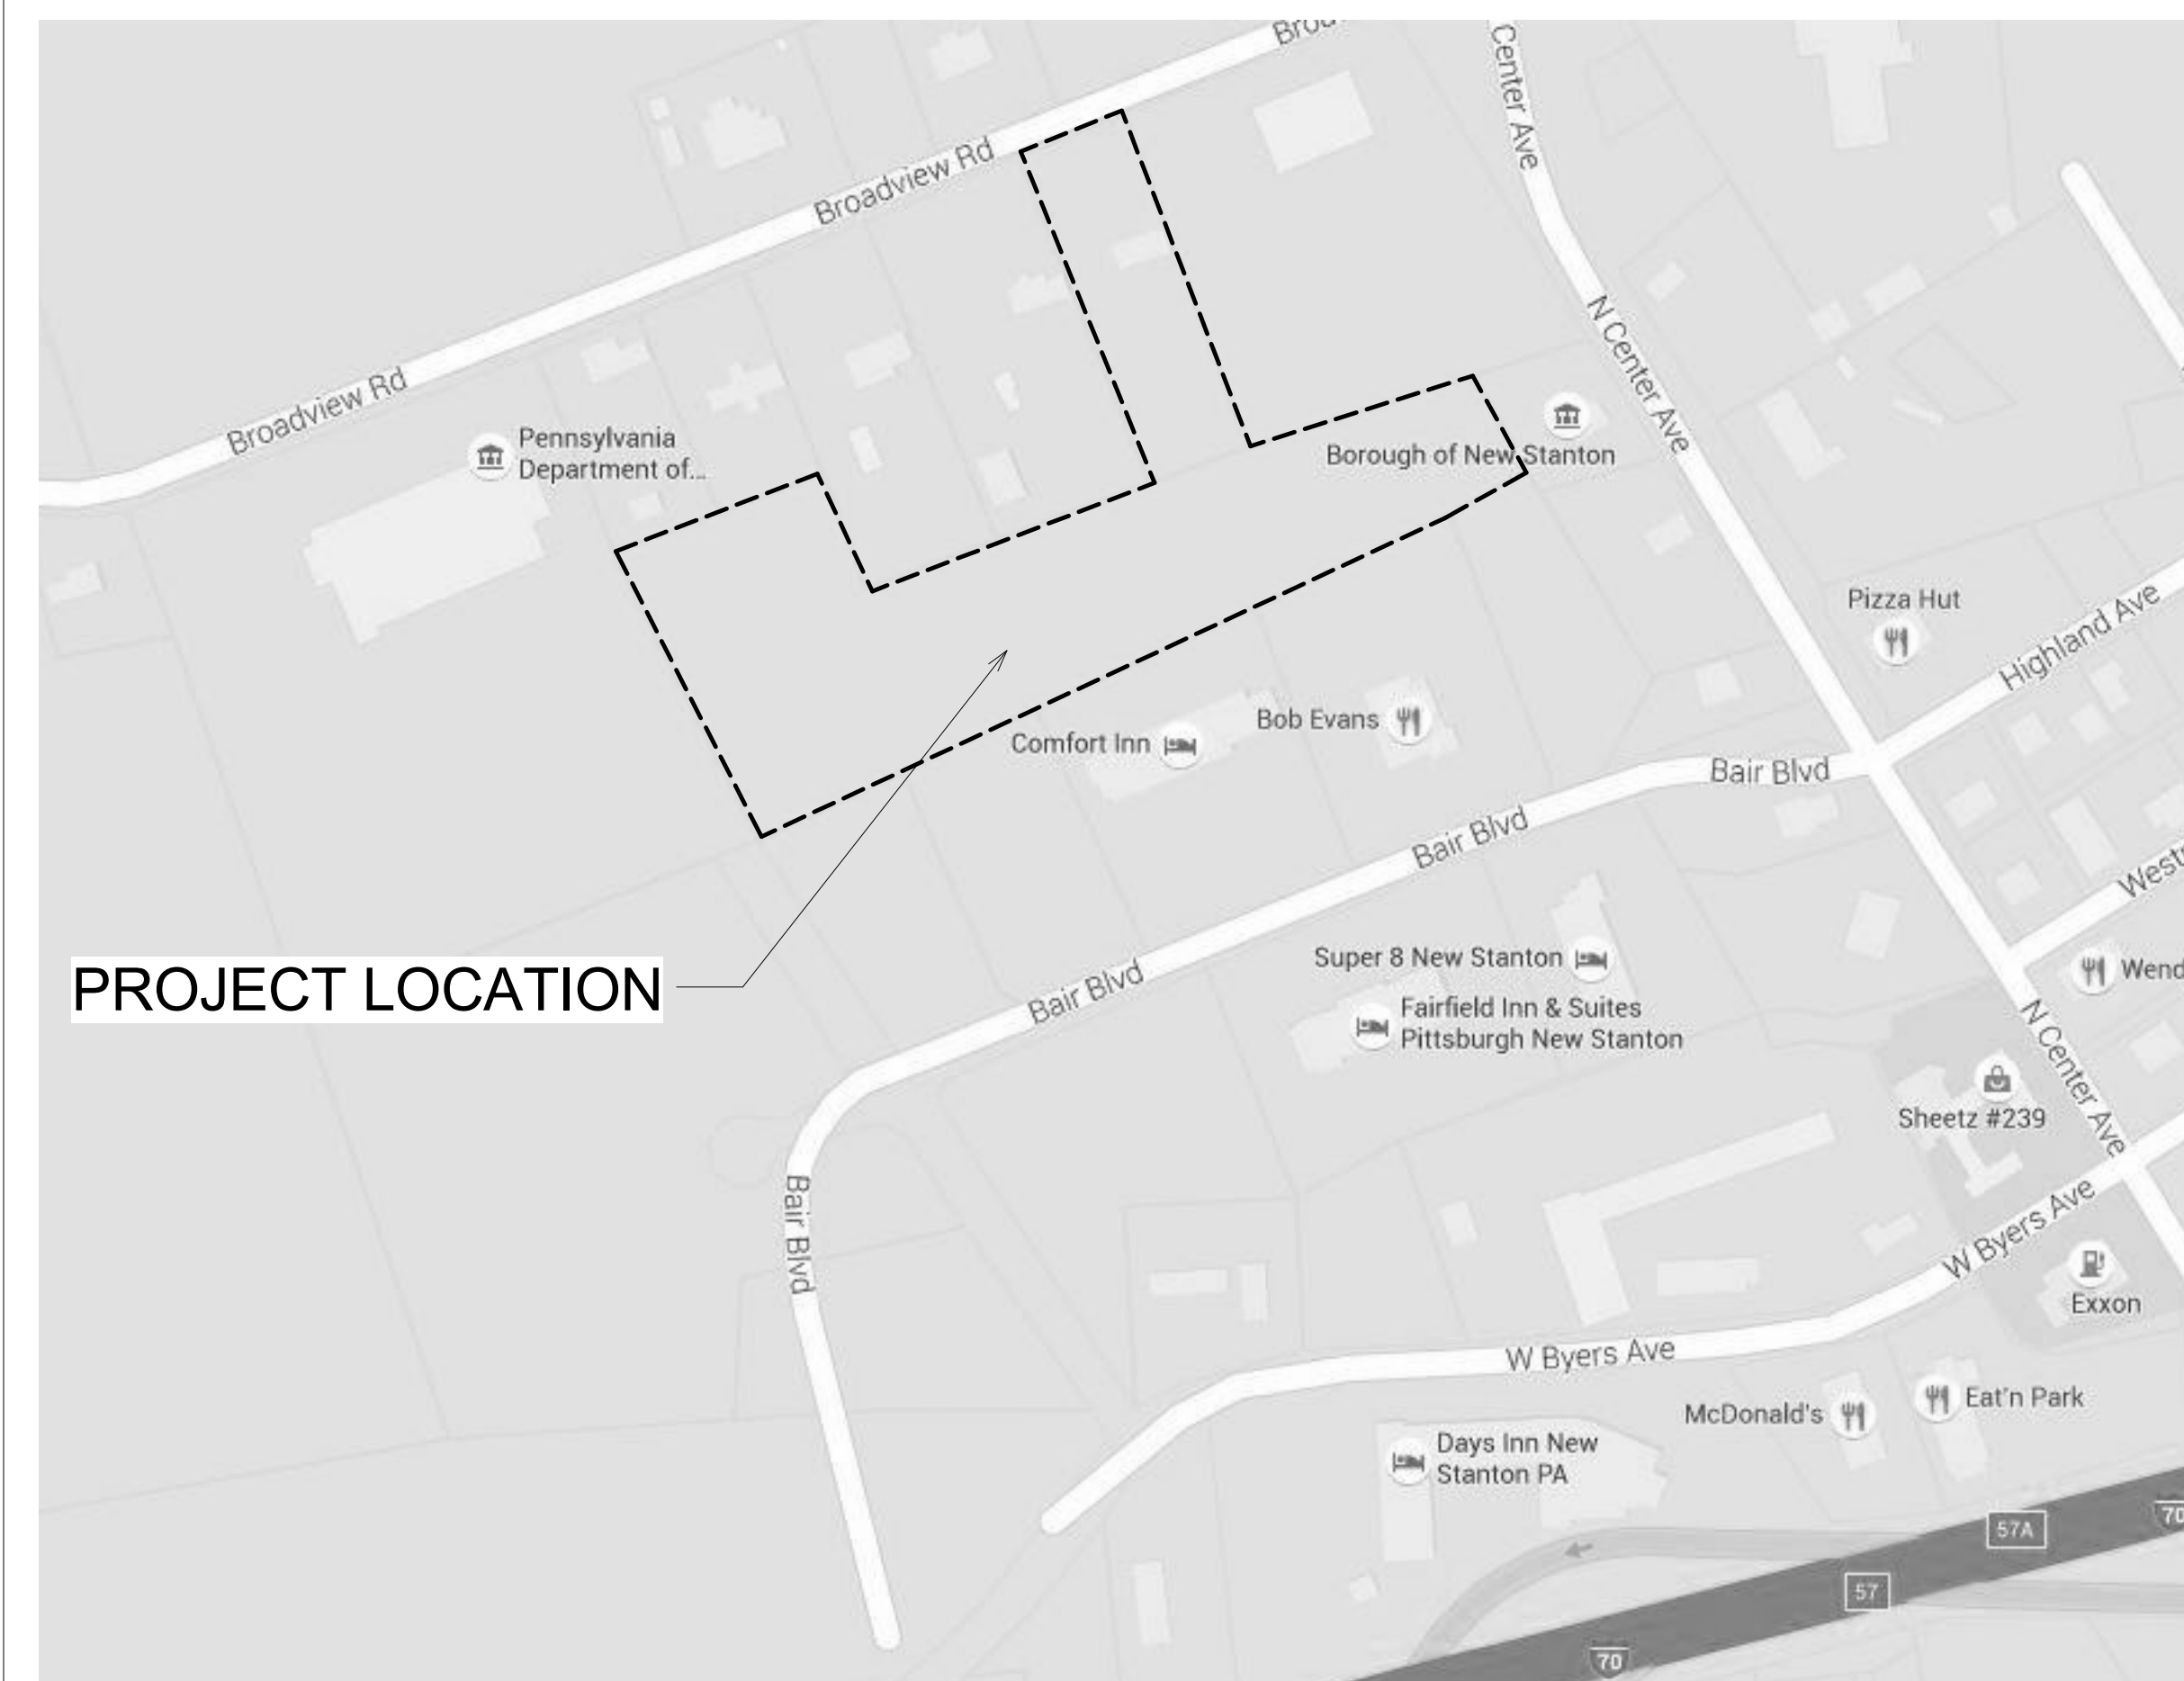

© 2016 JMAC Architects