




BASE4

BASE4
3858 GLADES ROAD, #31
BOCA RATON, FLORIDA 33434
1.720.725.4544 www.base-4.com

SEAL

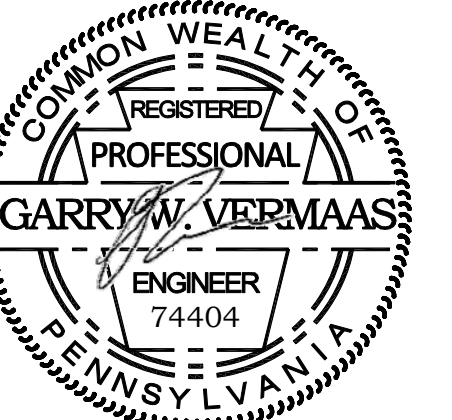

GARRY VERMAAS, Ph.D., PE
3015 LINDS
9011 EDGEWATER BEND
PARKLAND, FLORIDA, 33076



ISSUE:

Issued for Permit
08.05.2016

PROJECT: 16-018

Hampton Inn & Suites

New Stanton, PA 15672

OWNER:

Stanton Hospitality LLC

52 Blueberry Lane,
Grove City, PA 16127

No.	Issue Date	Project Status

DATE 2016.08.05

DRAWN BY JP

CHECKED BY GWV

SCALE AS NOTED


PROJECT NO. B4-67-1603

SHEET NAME

THIRD & FOURTH
FLOOR PLUMBING
PLAN

SHEET NO.


P204

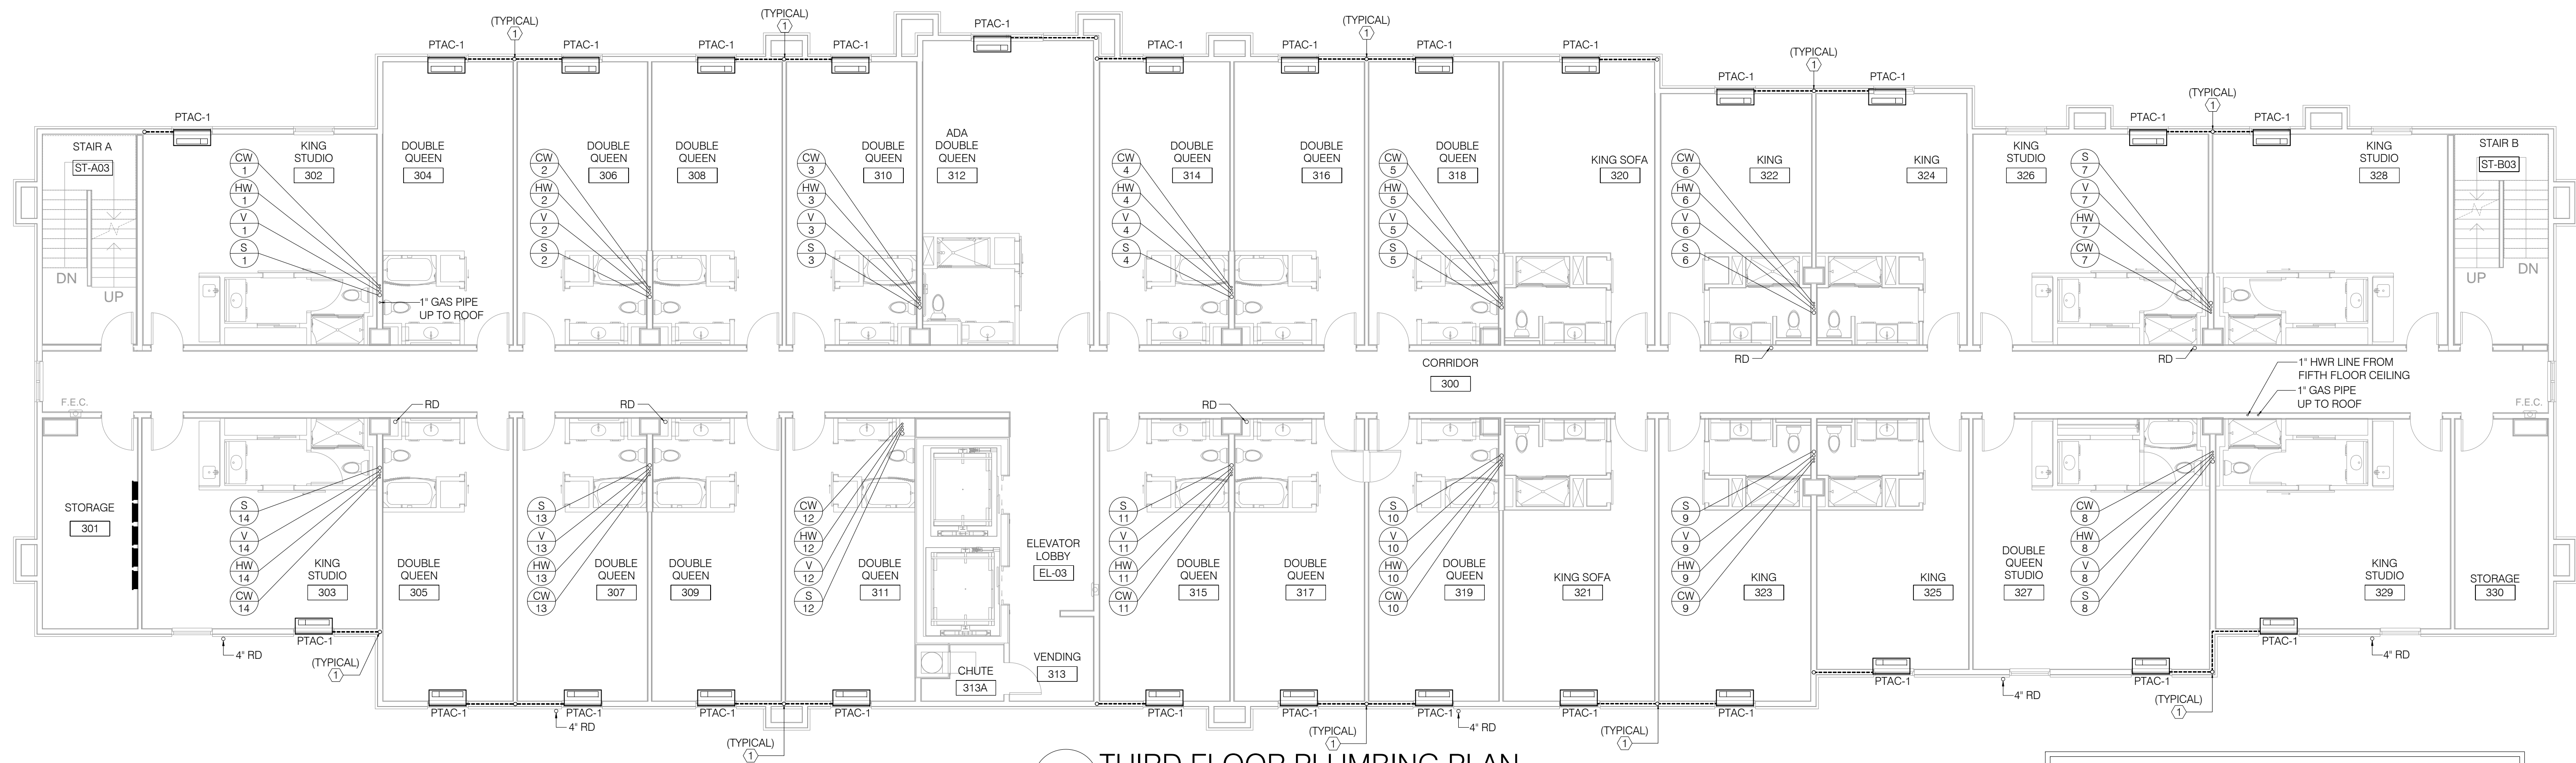

01 THIRD FLOOR PLUMBING PLAN
SCALE: 1/8"=1'-0"

KEY NOTES:

- ① 1-1/4" CONDENSATE RISER DOWN. SEE LOWER FLOOR PLANS FOR CONTINUATION.
TYPICAL FOR ALL PTAC UNITS CONDENSATE DRAINAGE UNLESS NOTED
OTHERWISE.

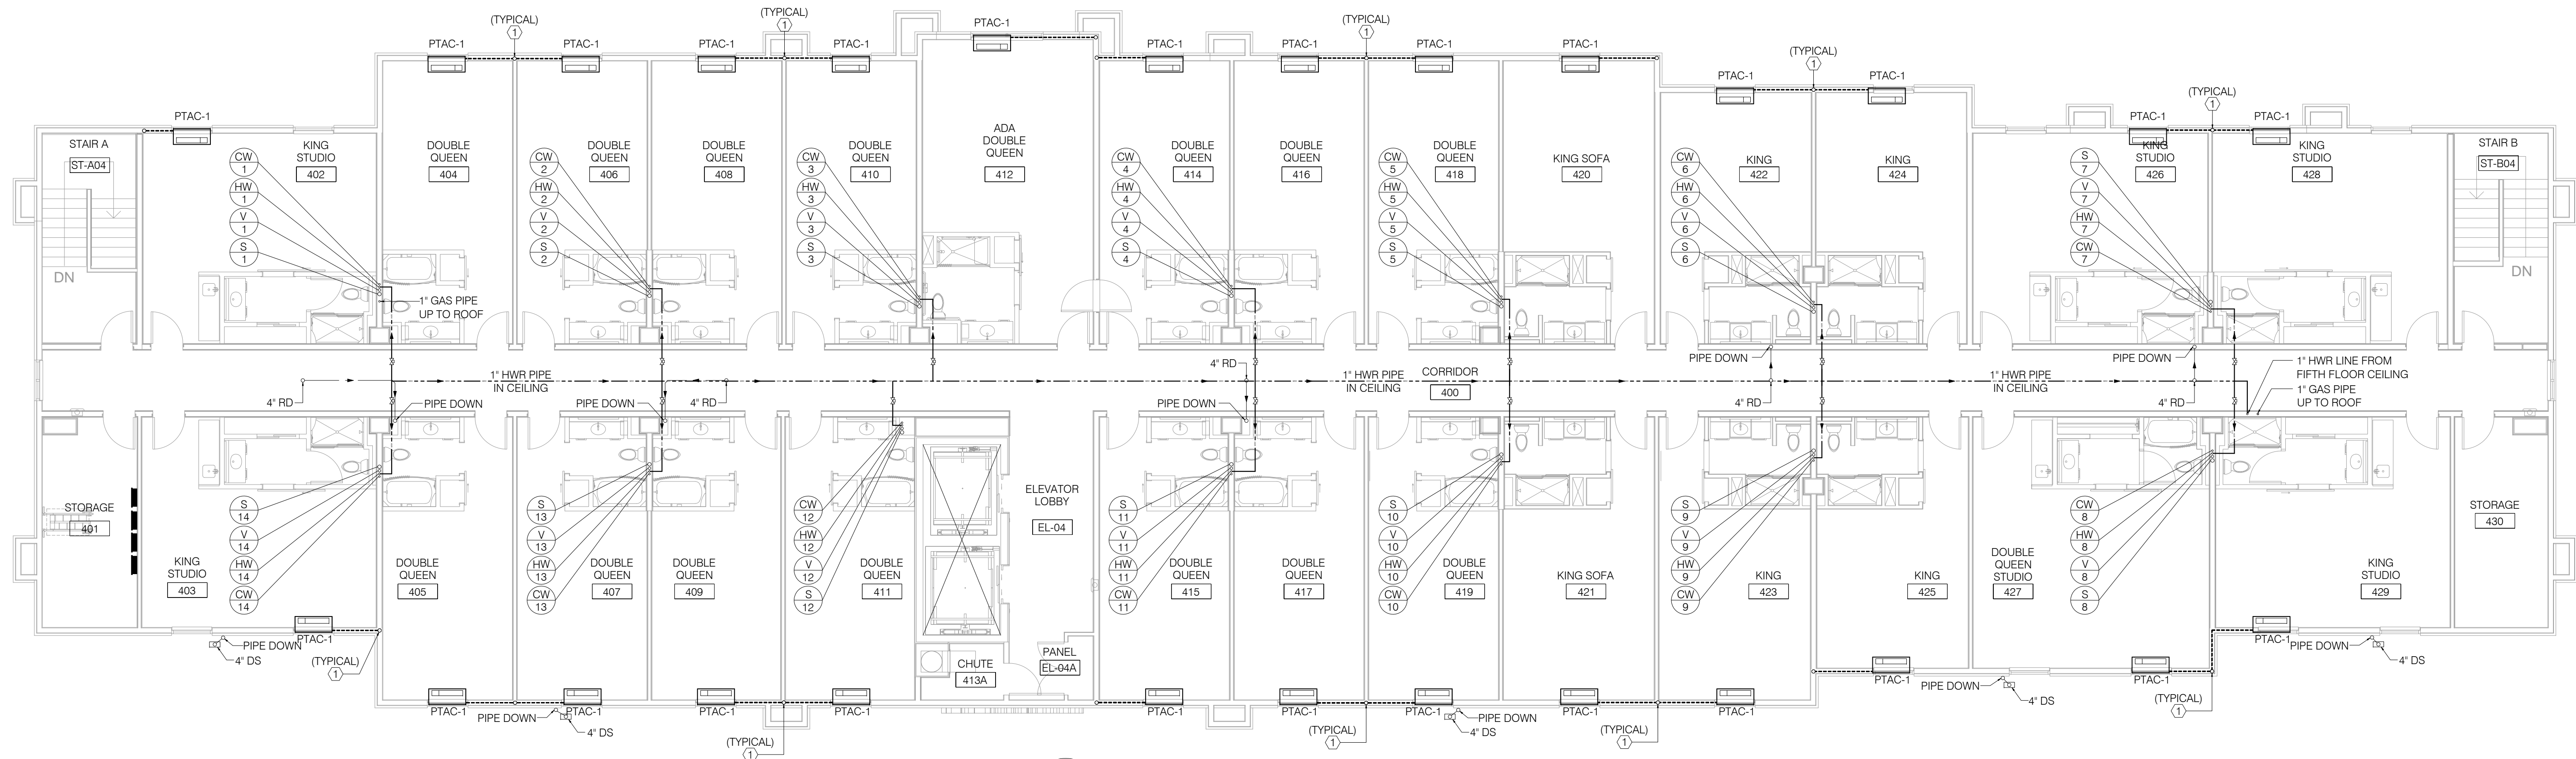

01 FOURTH FLOOR PLUMBING PLAN
SCALE: 1/8"=1'-0"

KEY NOTES:

- ① 1-1/4" CONDENSATE RISER DOWN. SEE LOWER FLOOR PLANS FOR CONTINUATION.
TYPICAL FOR ALL PTAC UNITS CONDENSATE DRAINAGE UNLESS NOTED
OTHERWISE.